



NEW CONSTRUCTION FOR
RESIDENCE AT MERIDIAN
 CEDAR & OAK, INC.

SHEET INDEX:


- A000 COVER SHEET - OVERALL FLOOR PLAN
- A001 SITE PLAN LAYOUT
- A002 FLOOR PLAN - DIMENSION - MAIN LEVEL
- A003 FLOOR PLAN - DIMENSION - UPPER LEVEL
- A010 REFLECTED CEILING PLAN & HVAC - MAIN LEVEL
- A011 REFLECTED CEILING PLAN & HVAC - UPPER LEVEL
- A012 ELECTRICAL - MAIN LEVEL
- A013 ELECTRICAL - UPPER LEVEL

- A501 CABINET - FRONT ENTRY
- A502 CABINET - LIVING
- A503 CABINET - KITCHEN
- A504 CABINET - KITCHEN ISLAND
- A505 CABINET - PANTRY
- A506 CABINET - DINING
- A507 CABINET - MUD ROOM
- A508 CABINET - STAIR 2
- A509 CABINET - POWDER BATH
- A510 CABINET - HALL 3
- A511 CABINET - SUNROOM
- A512 CABINET - STAIR 1
- A513 CABINET - GUEST BATH
- A514 CABINET - GUEST CLOSET
- A515 CABINET - LAUNDRY 1

SHEET INDEX (CONT'D):

- A516 CABINET - PRIMARY CLOSET
- A517 CABINET - PRIMARY BATH
- A518 CABINET - PRIMARY BEDROOM
- A519 CABINET - LAUNDRY 2
- A520 CABINET - BATH 3 (GIRLS)
- A521 CABINET - CLOSET (GIRLS)
- A522 CABINET - BATH 4 (BOYS)
- A523 CABINET - CLOSET (BOYS)
- A524 CABINET - MEDIA
- A525 CABINET - MEDIA HALF BATH
- A526 CABINET - FLEX SPACE
- A527 CABINET - BUNK ROOM
- A528 CABINET - WORKOUT
- A529 CABINET - OUTDOOR LIVING
- A530 CABINET - POOL BATH & SHOWER
- A531 CABINET - PRIMARY BEDROOM FOYER
- A532 CABINET - GUEST BEDROOM


CABINET SET

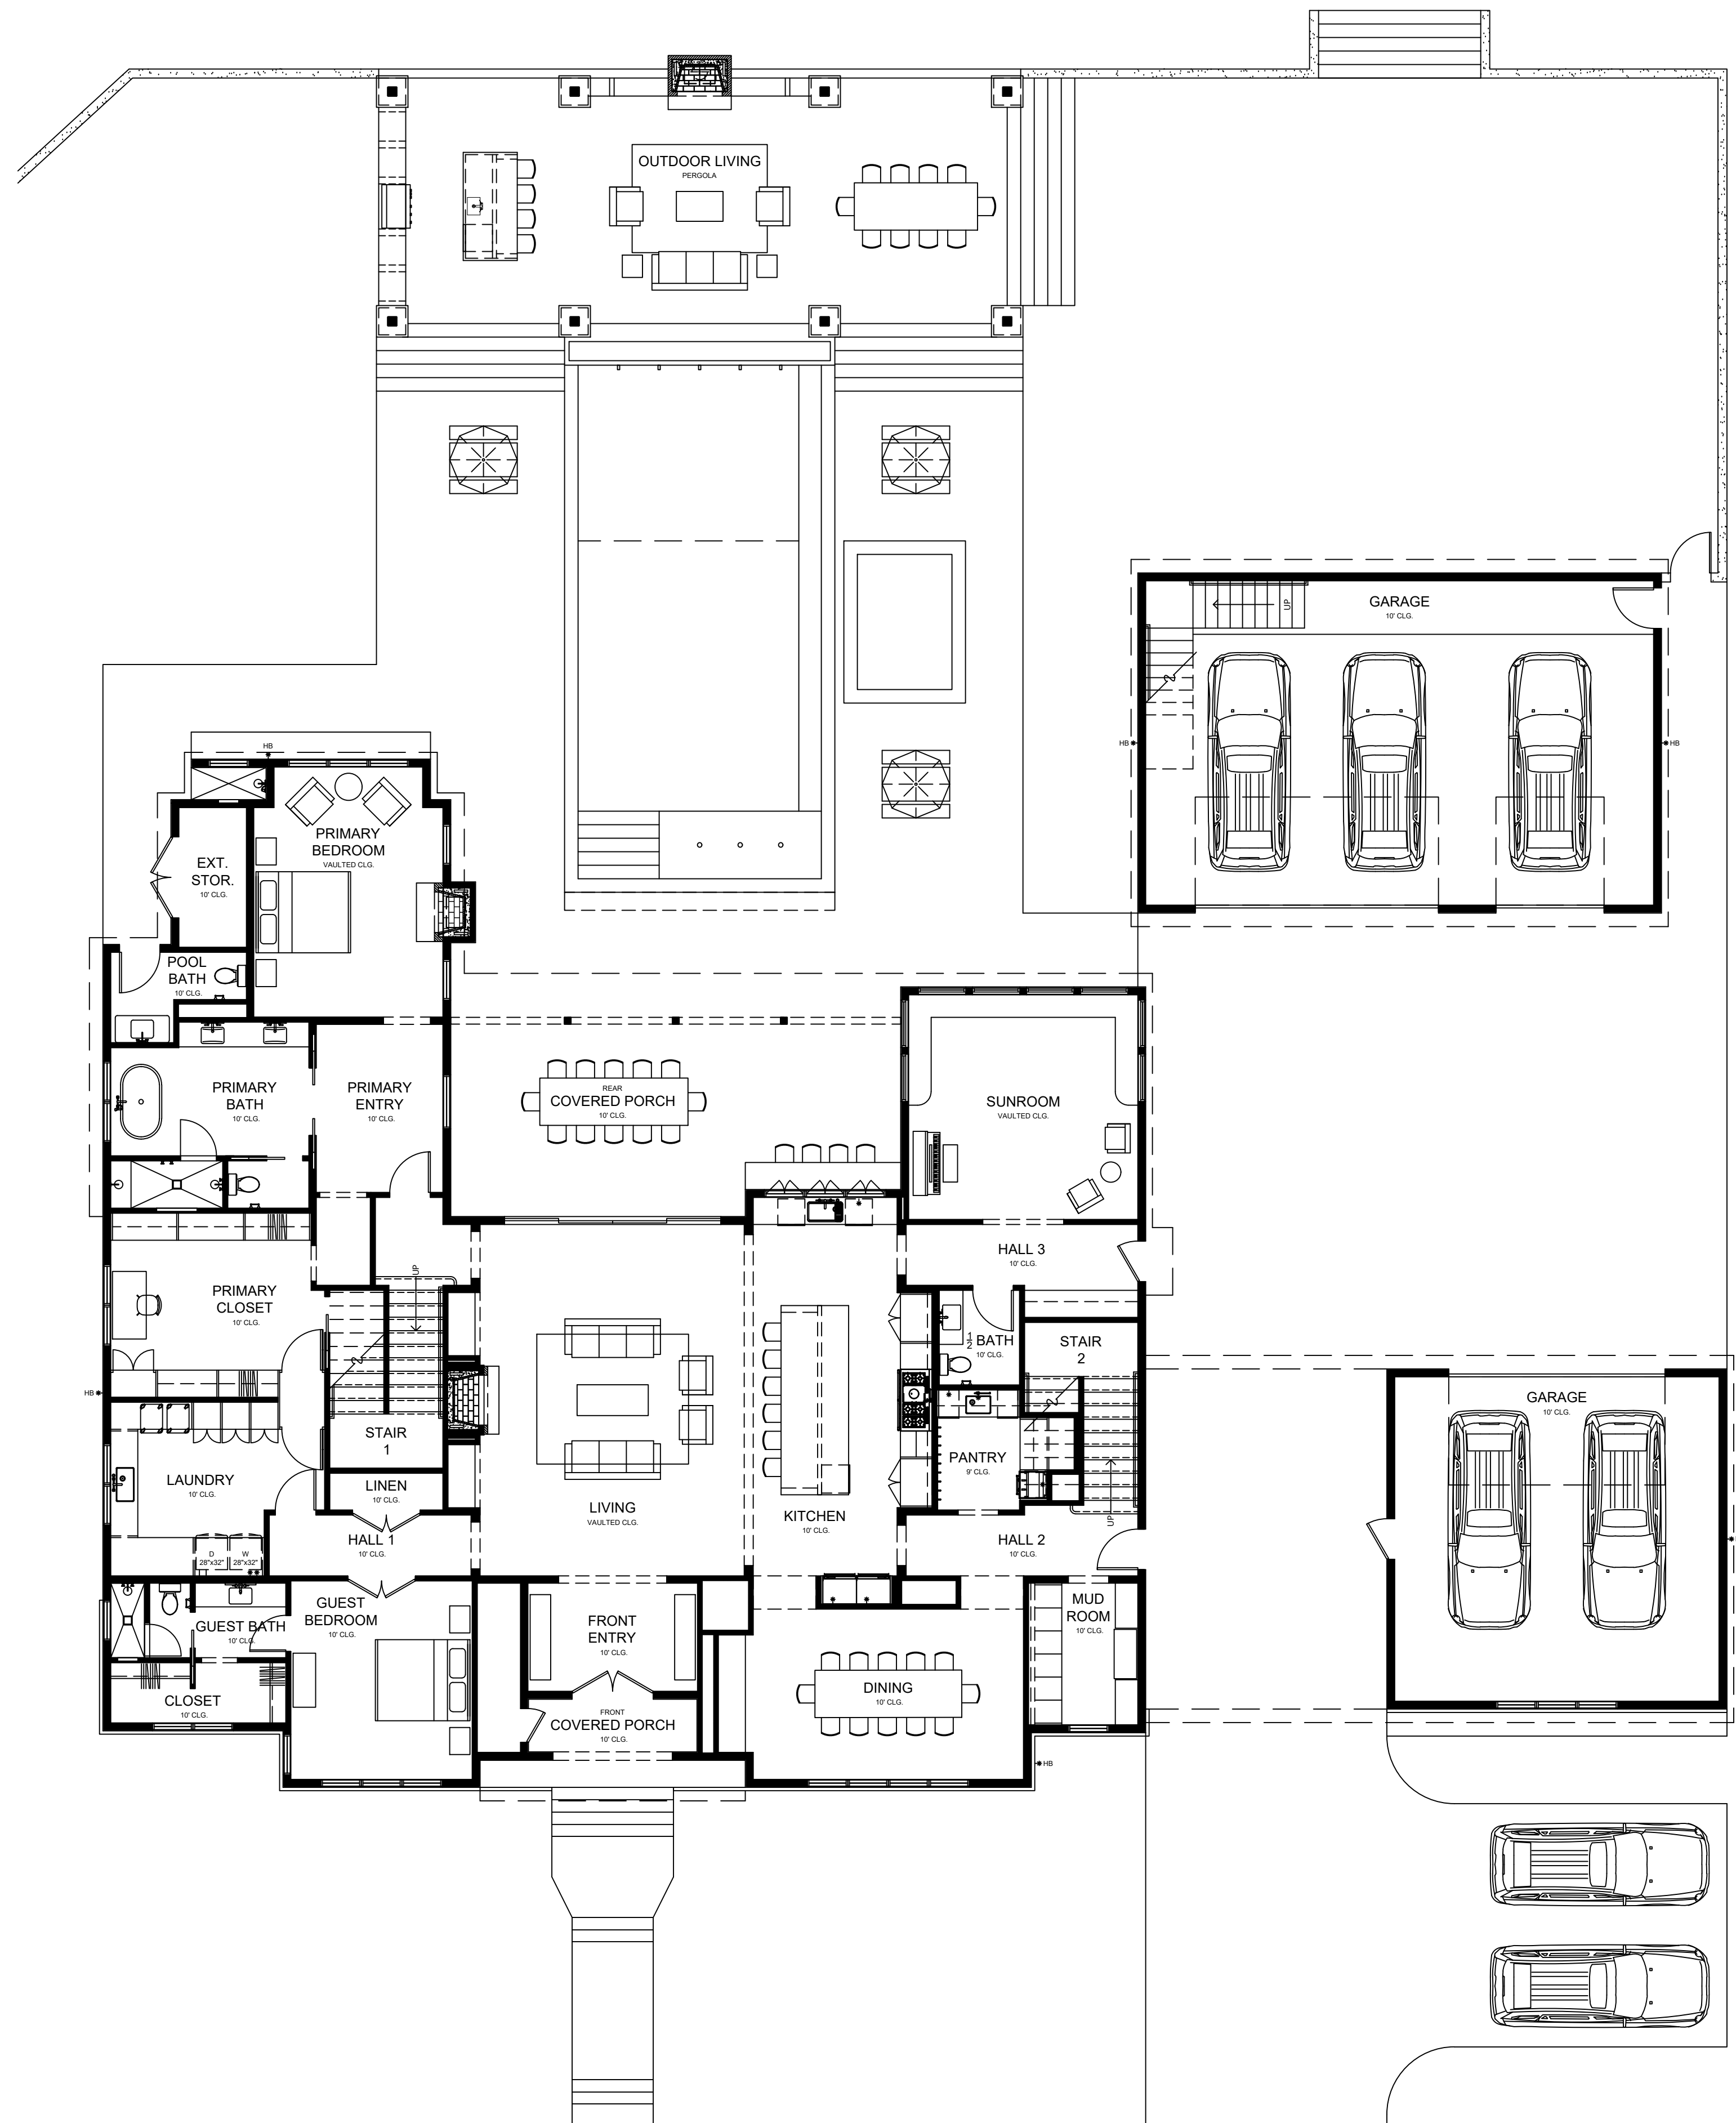

1

FLOOR PLAN - MAIN LEVEL
 1/8" = 1'-0"
 0 8 16 32
 FOR REFERENCE ONLY; DESIGN BY OTHERS

REVISIONS	
NO.	DATE

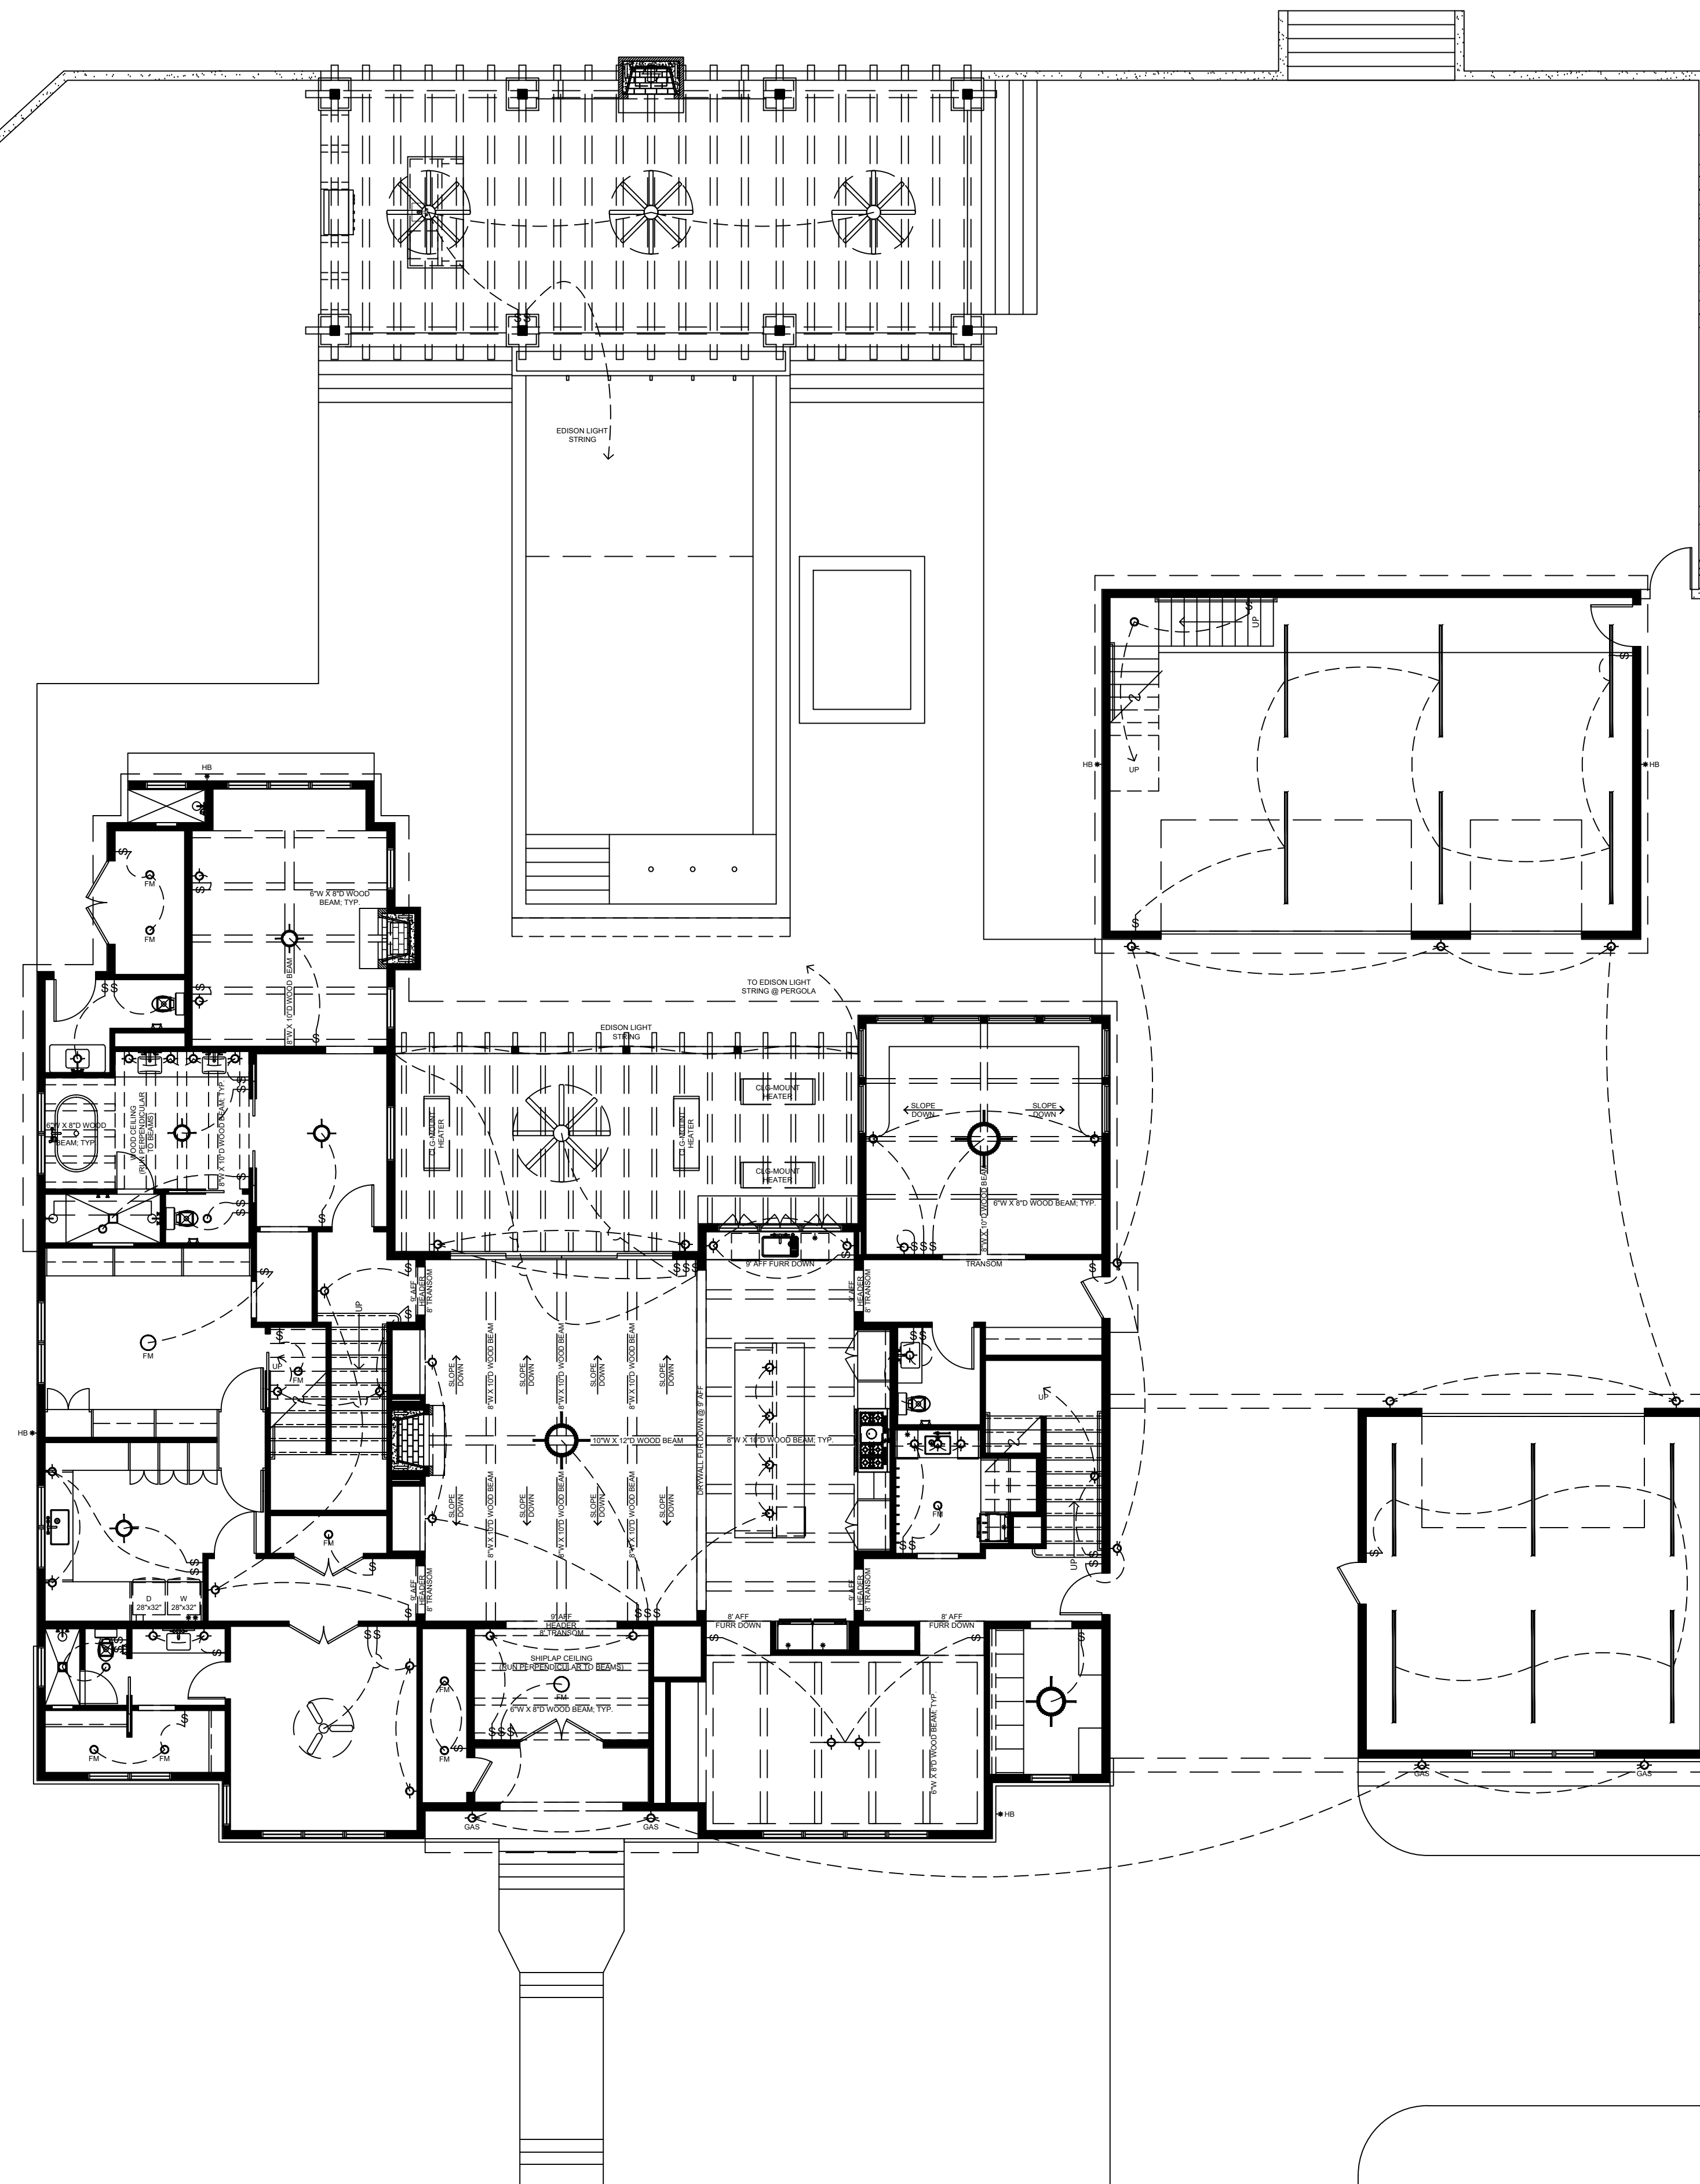

RCP LEGEND:

- RECESSED LIGHT FIXTURE
 - ⬆️ DIRECTIONAL RECESSED LIGHT FIXTURE
 - ⊙ FLUSH-MOUNT LIGHT FIXTURE
 - ⊖ PENDANT LIGHT FIXTURE
 - ⊖ WALL SCONCE LIGHT FIXTURE
 - ⊠ EXHAUST FAN
 - ⊖⊖ HANGING PENDANT MULTI-LIGHT FIXTURE
 - ⊖ CEILING FAN
- * SOME SYMBOLS MAY NOT BE USED ON PLAN


REVISIONS	
NO.	DATE



1

REFLECTED CEILING PLAN - MAIN LEVEL



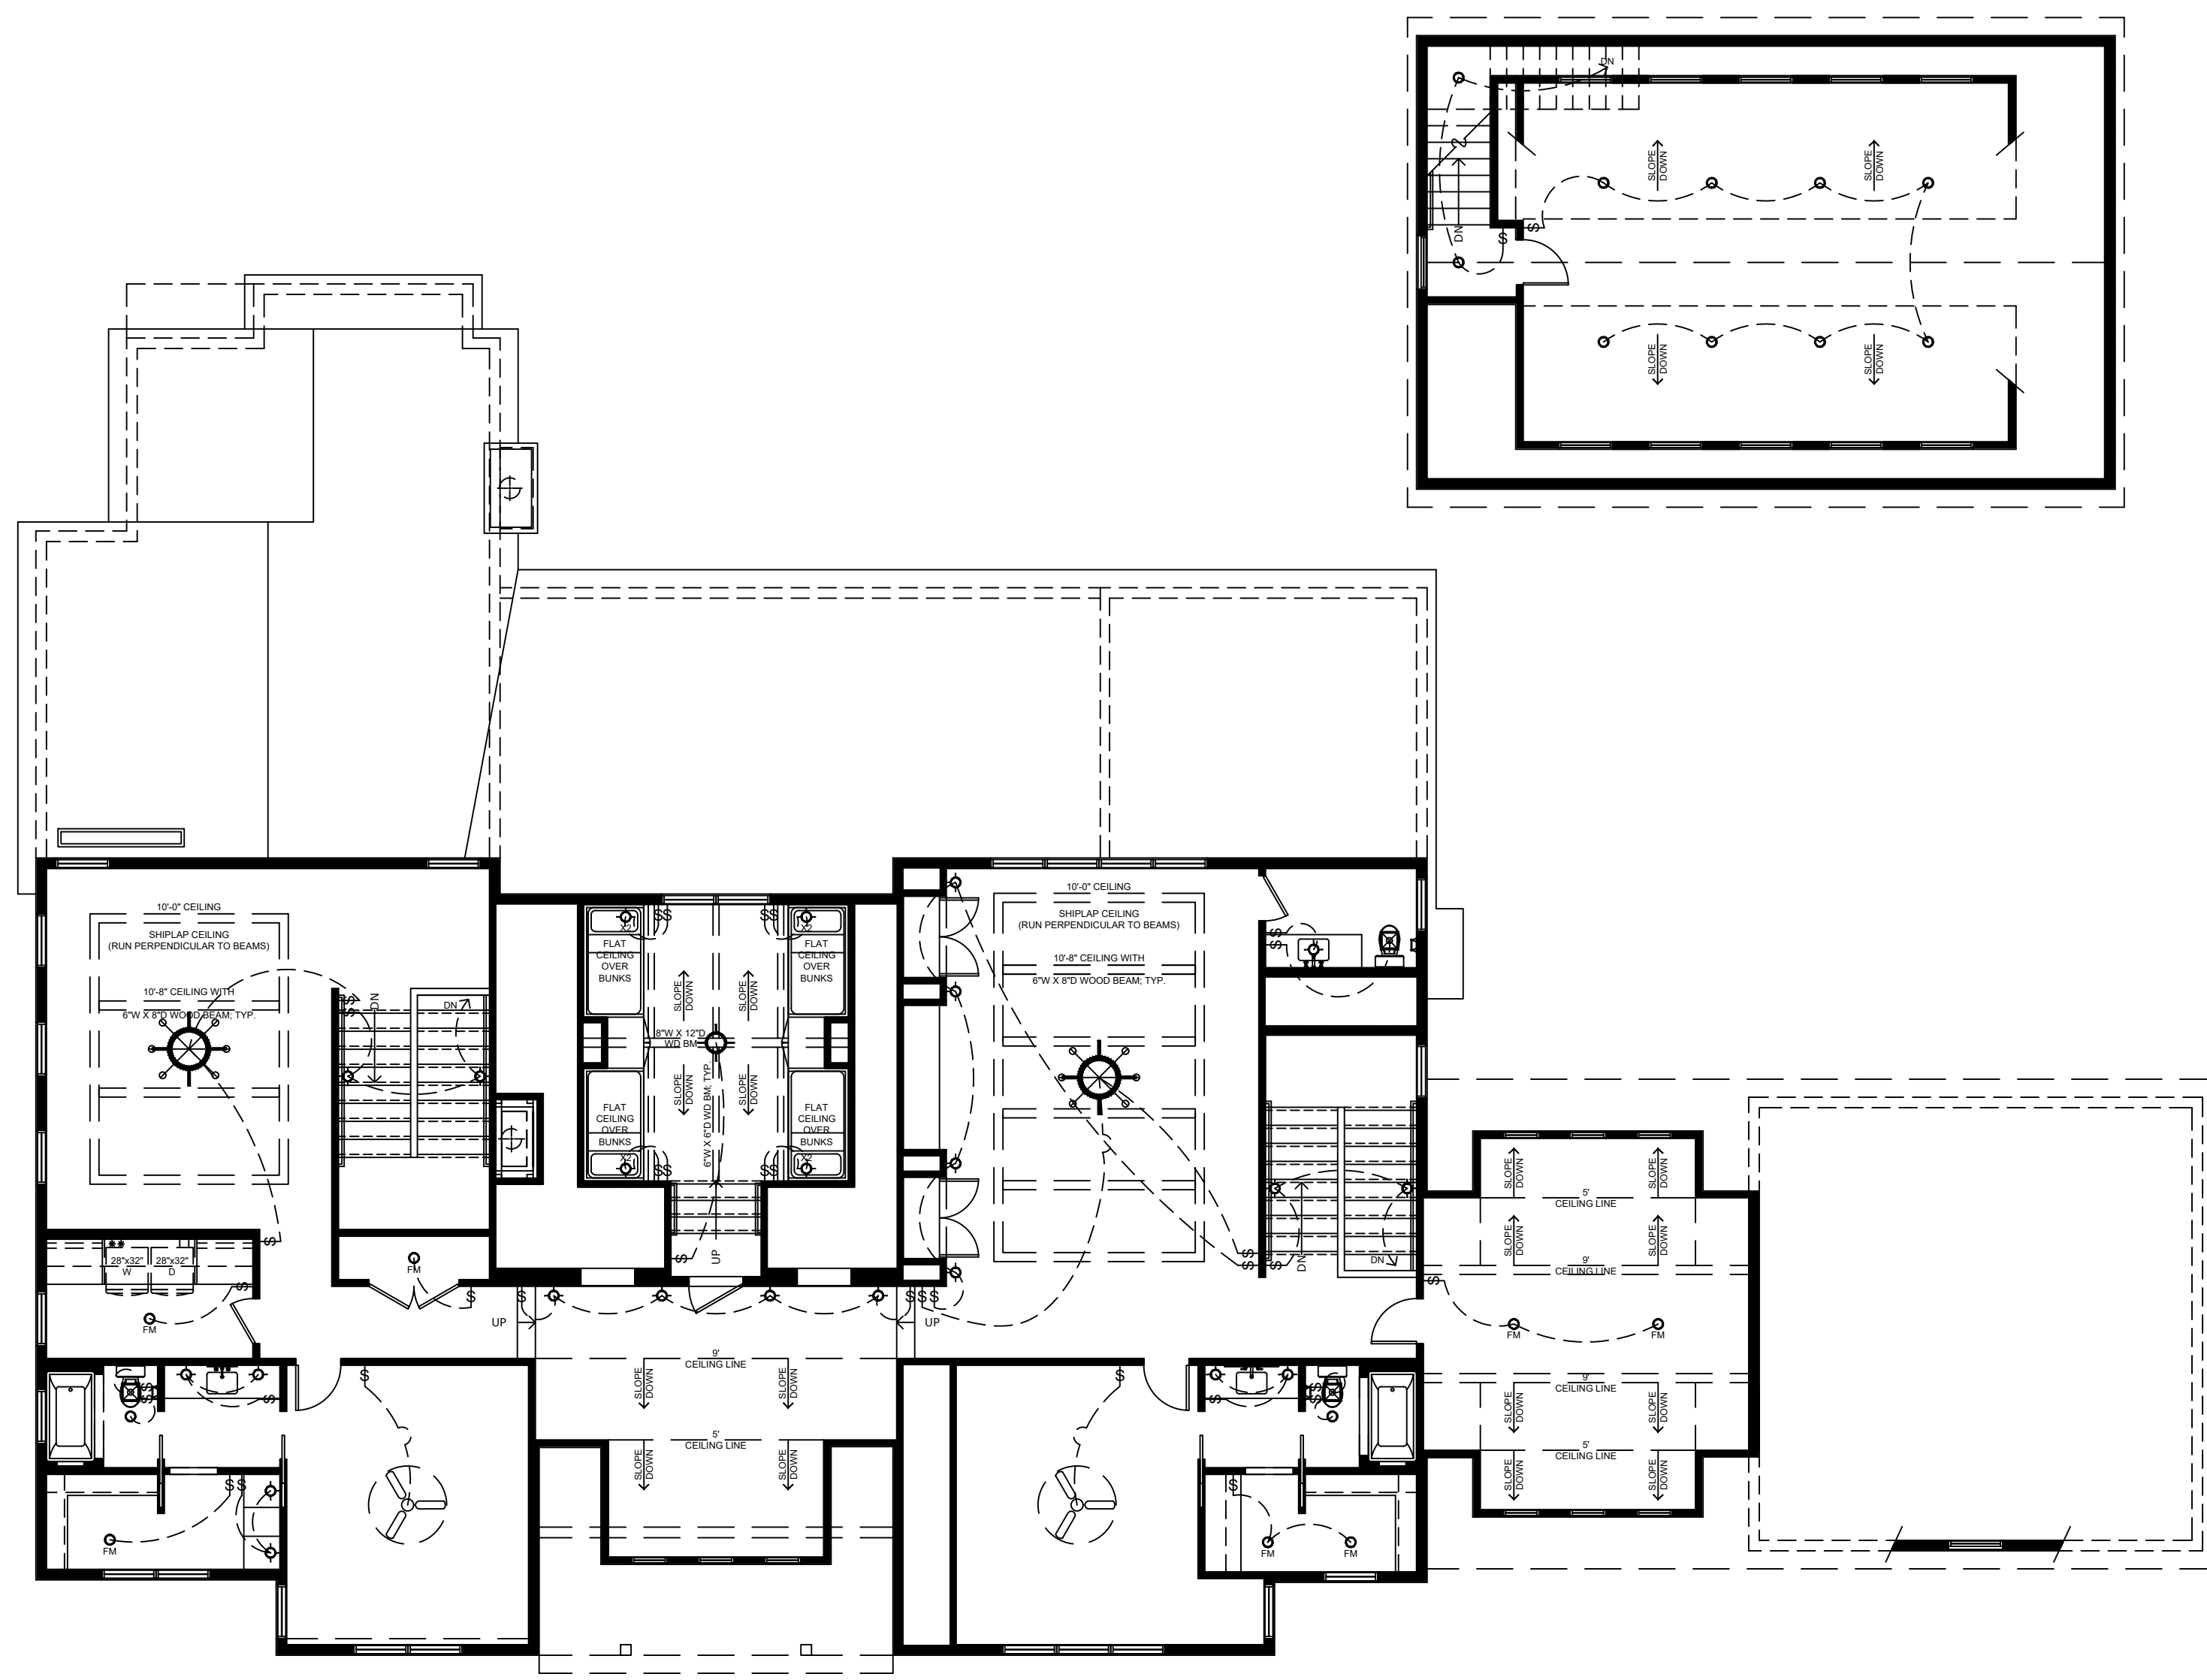

RCP LEGEND:

- RECESSED LIGHT FIXTURE
 - ◡ DIRECTIONAL RECESSED LIGHT FIXTURE
 - ⊙ FLUSH-MOUNT LIGHT FIXTURE
 - ⊖ PENDANT LIGHT FIXTURE
 - ⊖ WALL SCONCE LIGHT FIXTURE
 - ☒ EXHAUST FAN
 - ⊖ HANGING PENDANT MULTI-LIGHT FIXTURE
 - ⊖ CEILING FAN
- * SOME SYMBOLS MAY NOT BE USED ON PLAN

COPYRIGHT 2023
 PLAN & SIMPLE LLC

DATE:
11/05/2023

REVISIONS	
NO.	DATE

PROJECT NO.
2023-06

SHEET NO.
A011

REFLECTED CEILING PLAN
 UPPER LEVEL



1

REFLECTED CEILING PLAN - UPPER LEVEL

